



SITE PLAN - OVERALL

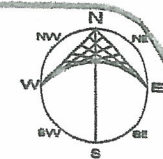

ISSUED FOR CONSTRUCTION

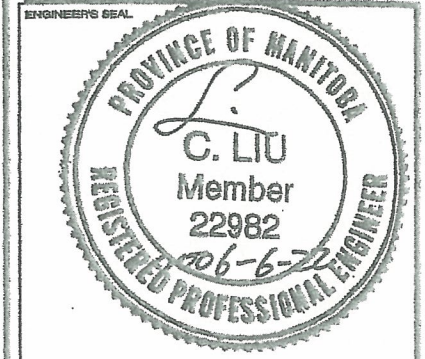

REVISION			
NO.	DATE	DESCRIPTION	INITIAL
02	06/06/22	ISSUED FOR CONSTRUCTION	SEM
01	06/06/05	ISSUED FOR CONSTRUCTION	J.M.

DATE	DRAWN	CHECKED







COPYRIGHT (2005)
 COPYRIGHT RESERVED. THIS DRAWING AND DESIGN IS AND AT ALL TIMES REMAINS THE EXCLUSIVE PROPERTY OF DGH ENGINEERING LTD. AND SHALL NOT BE USED WITHOUT THE ENGINEER'S CONSENT IN WRITING.
 THE CONTRACTOR SHALL CHECK AND VERIFY ALL DIMENSIONS AND REPORT ALL ERRORS AND OMISSIONS TO THE ENGINEER IN WRITING. DO NOT SCALE THIS DRAWING. THIS DRAWING SHALL NOT BE USED FOR CONSTRUCTION OR BUILDING PERMIT PURPOSES UNTIL SEALED AND SIGNED.

18 AVIATION BLVD, ST. ANDREWS, MB R1A 8N5
 PHONE (204) 834-8846 FAX (204) 834-8836


CLIENT
MIAMI COLONY
 BOX 131
 MORDEN, MANITOBA
 R6M 1V9

PROJECT TITLE
EARTHEN MANURE STORAGE BASIN RM OF THOMPSON
 LEGAL DESCRIPTION
NE 4-4-6 W
 PROJECT NUMBER: 06-1-1400-006-10 DATE: JUNE 2006

MANURE TRANSFER SYSTEM - MANURE PIPING LAYOUT
 C-12 REV. 000

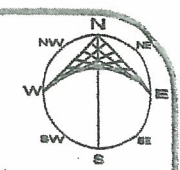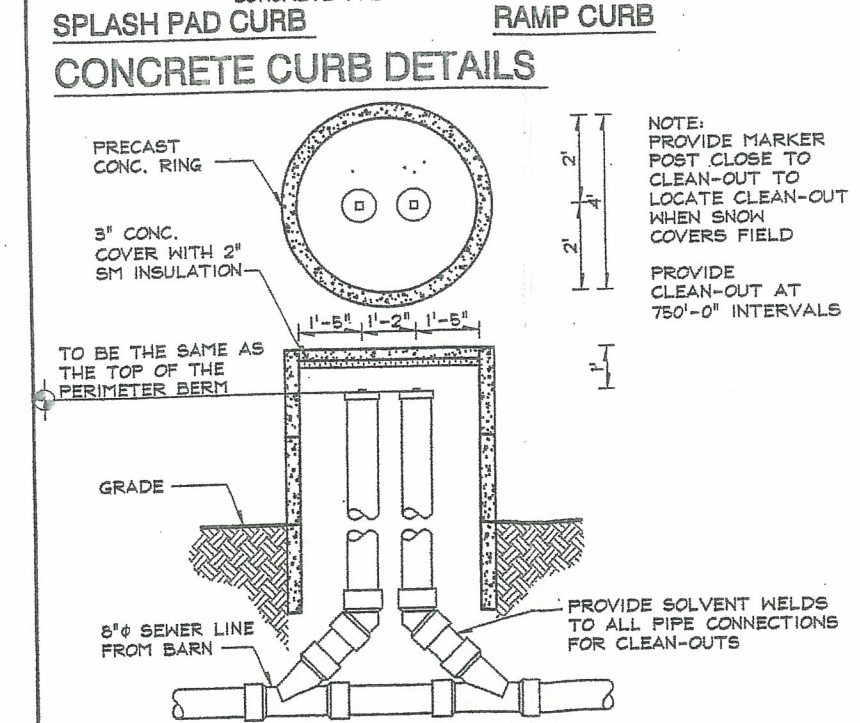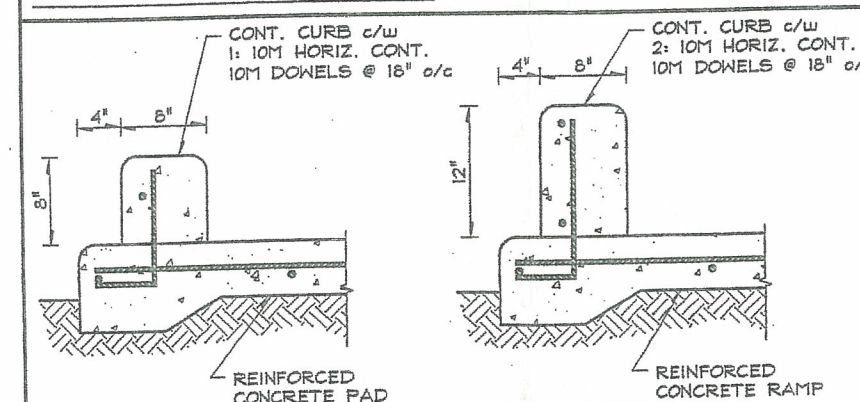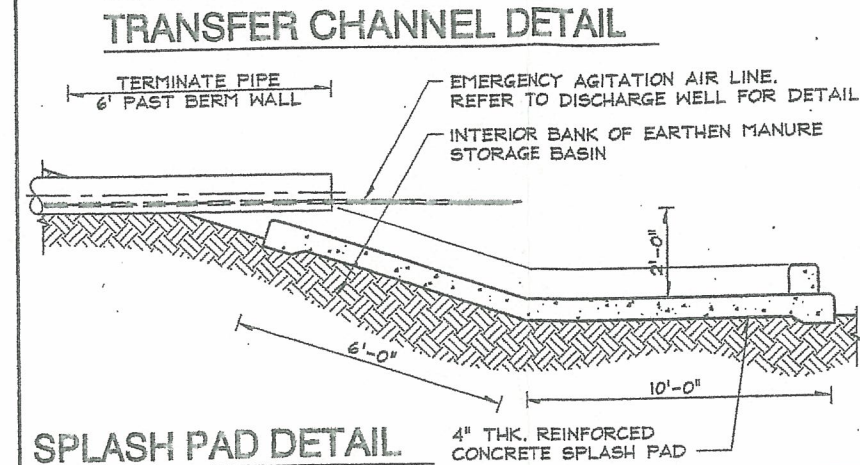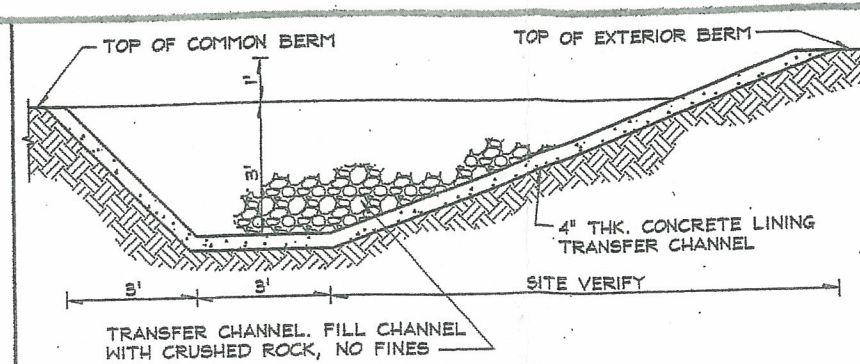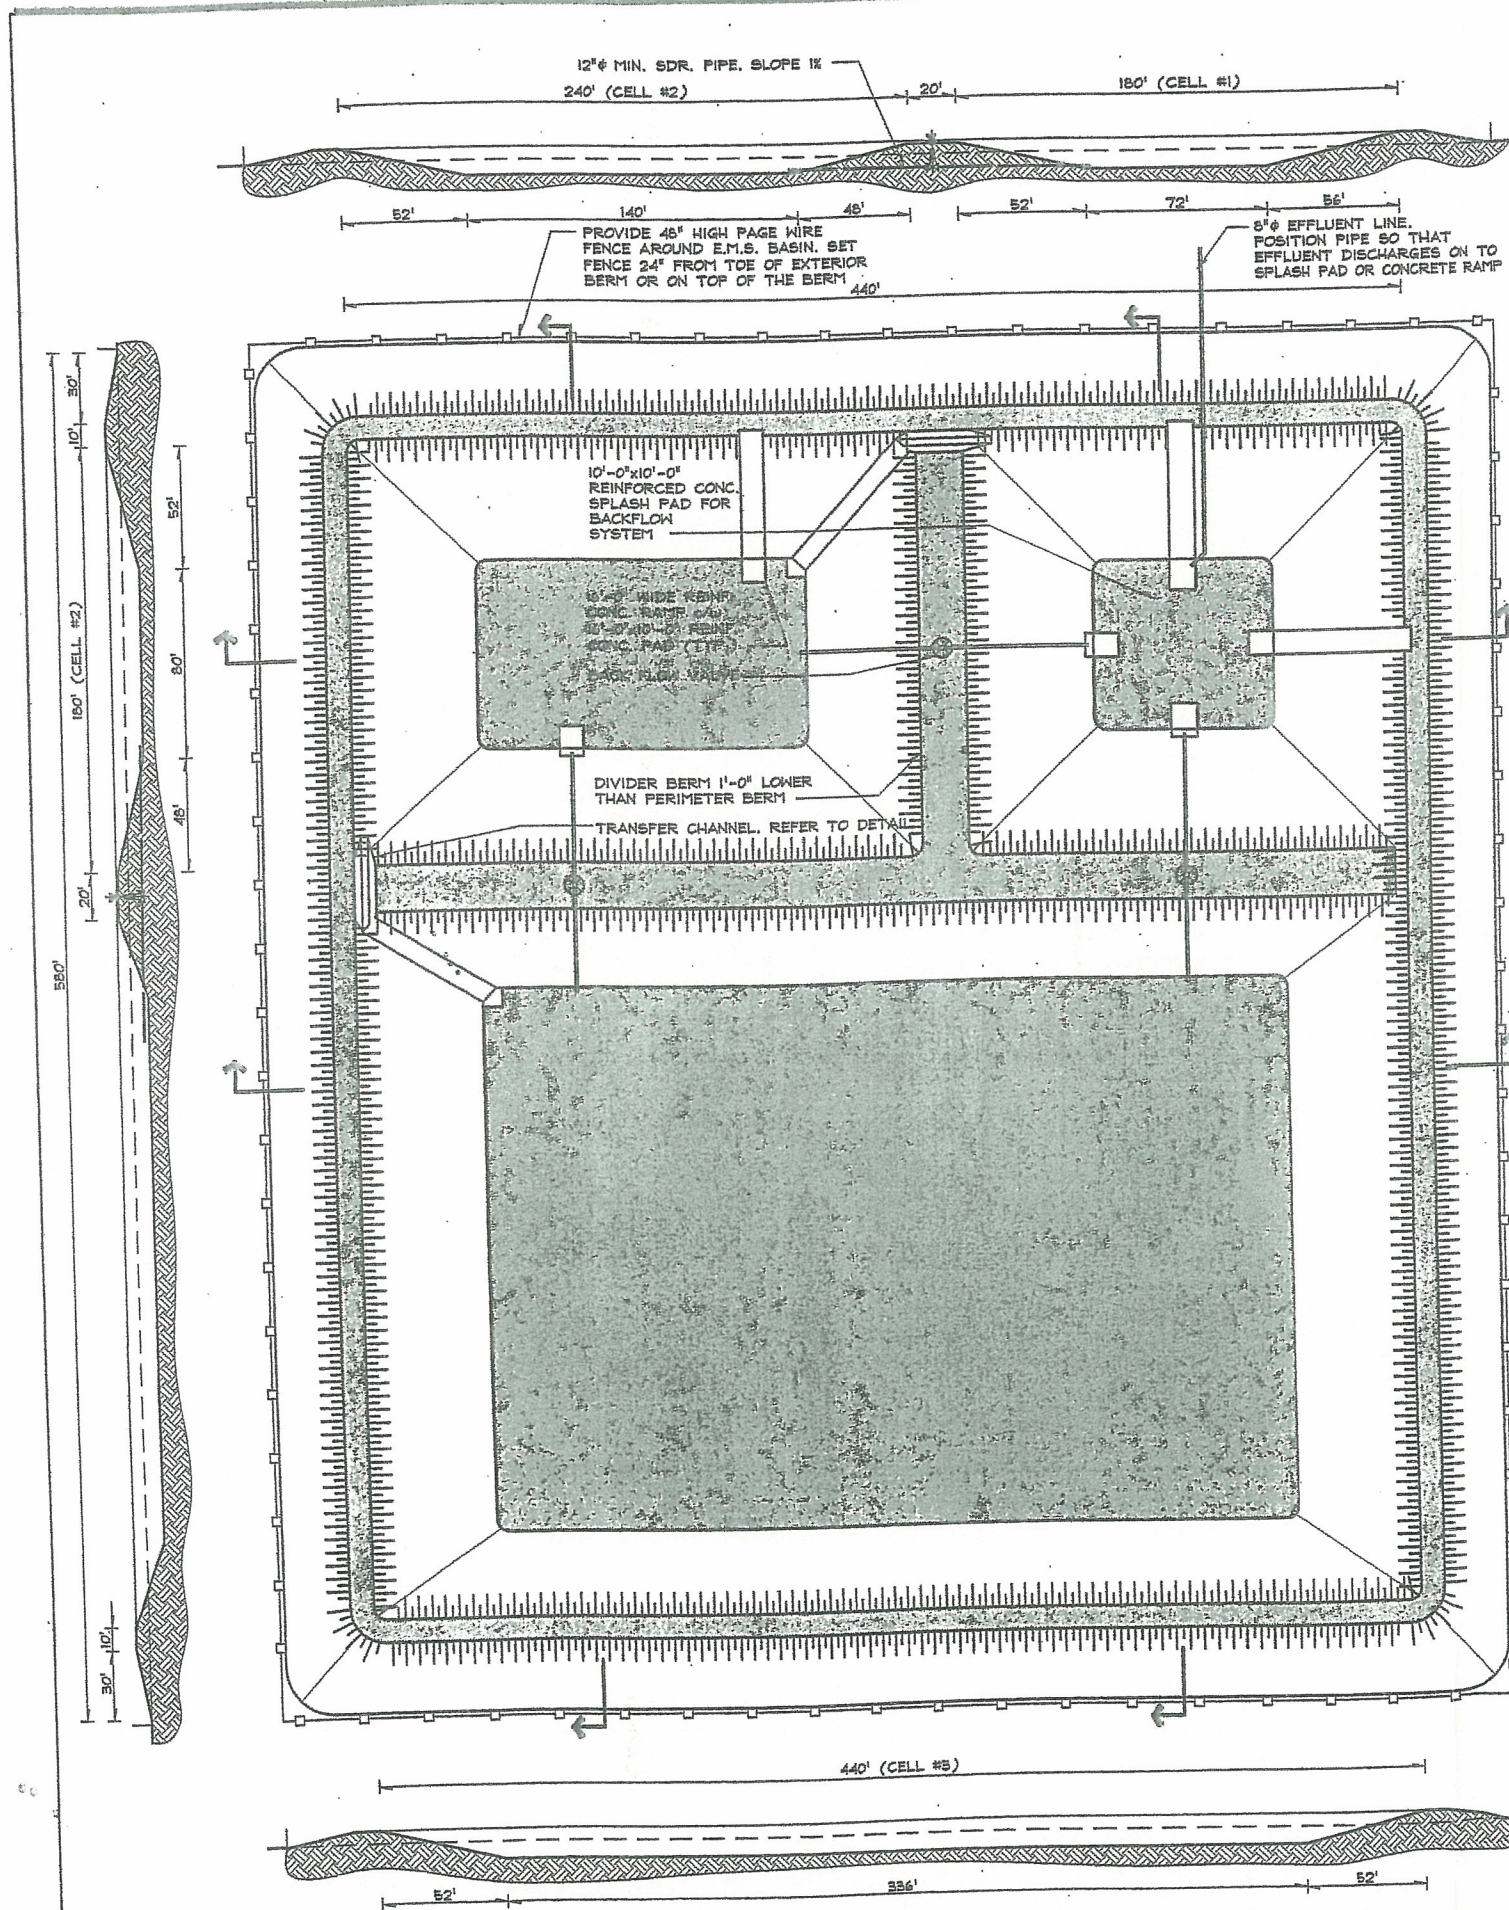

ISSUED FOR CONSTRUCTION

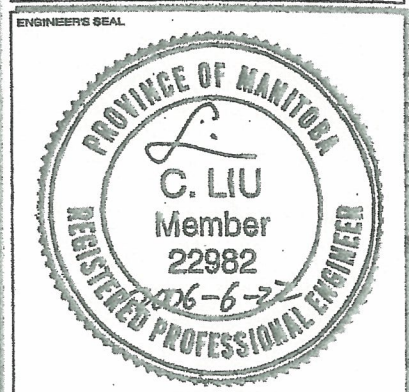

REVISION	DATE	DRAWN	CHECKED
02	06/06/22	ISSUED FOR CONSTRUCTION	SSM
01	06/05/22	ISSUED FOR CONSTRUCTION	JJM
NO.	DATE	DESCRIPTION	INITIAL


COPYRIGHT (2008)
 COPYRIGHT RESERVED. THIS DRAWING AND DESIGN IS AND AT ALL TIMES REMAINS THE EXCLUSIVE PROPERTY OF DGH ENGINEERING LTD AND SHALL NOT BE USED WITHOUT THE ENGINEER'S CONSENT IN WRITING.
 THE CONTRACTOR SHALL CHECK AND VERIFY ALL DIMENSIONS AND REPORT ALL ERRORS AND OMISSIONS TO THE ENGINEER IN WRITING. DO NOT SCALE THIS DRAWING. THIS DRAWING SHALL NOT BE USED FOR CONSTRUCTION OR BUILDING PERMIT PURPOSES UNTIL SEALED AND SIGNED.

DGH ENGINEERING LTD.
 PROFESSIONAL SERVICE - PRACTICAL SOLUTIONS
 12 AVIATION BLVD, ST. ANDREWS, MB R1A 8N6
 PHONE (204) 884-8848 FAX (204) 884-8865


CLIENT
 MIAMI COLONY
 BOX 131
 MORDEN, MANITOBA
 R6M 1V9

PROJECT TITLE
 EARTHEN MANURE STORAGE BASIN
 RM OF THOMPSON
LEGAL DESCRIPTION
 NE 4-4-6 W
 PROJECT NUMBER: 06-1-1400-006-10 DATE: JUNE 2022


PLAN VIEW, & DETAILS
 L1 R00

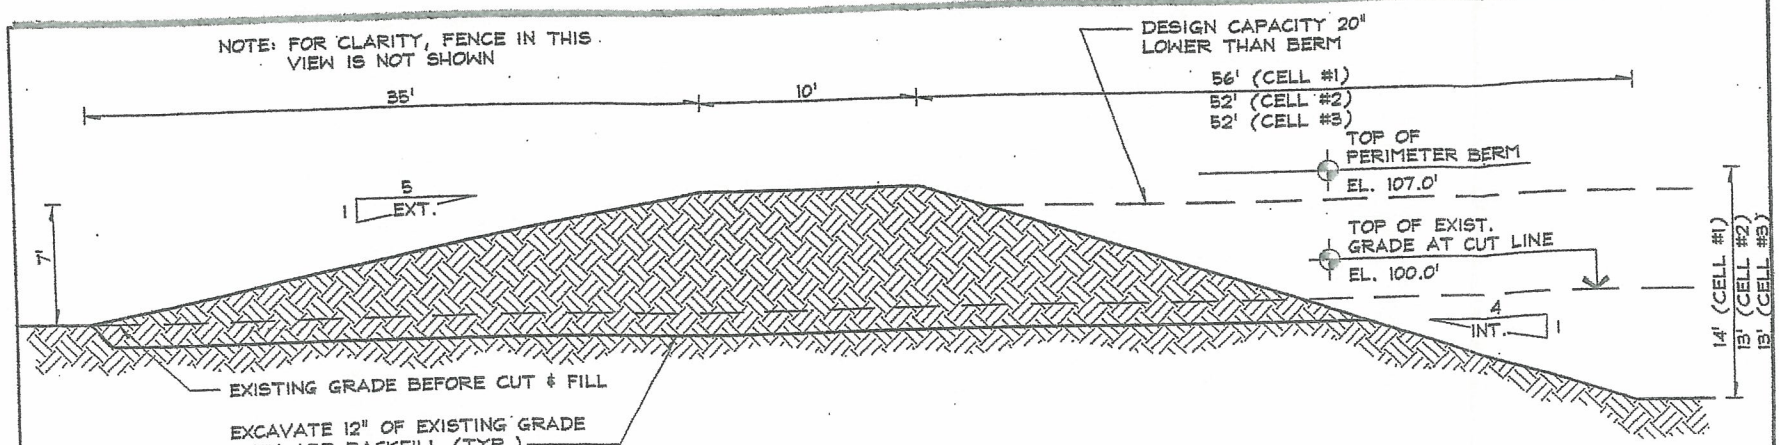

SECTION THRU PERIMETER BERM

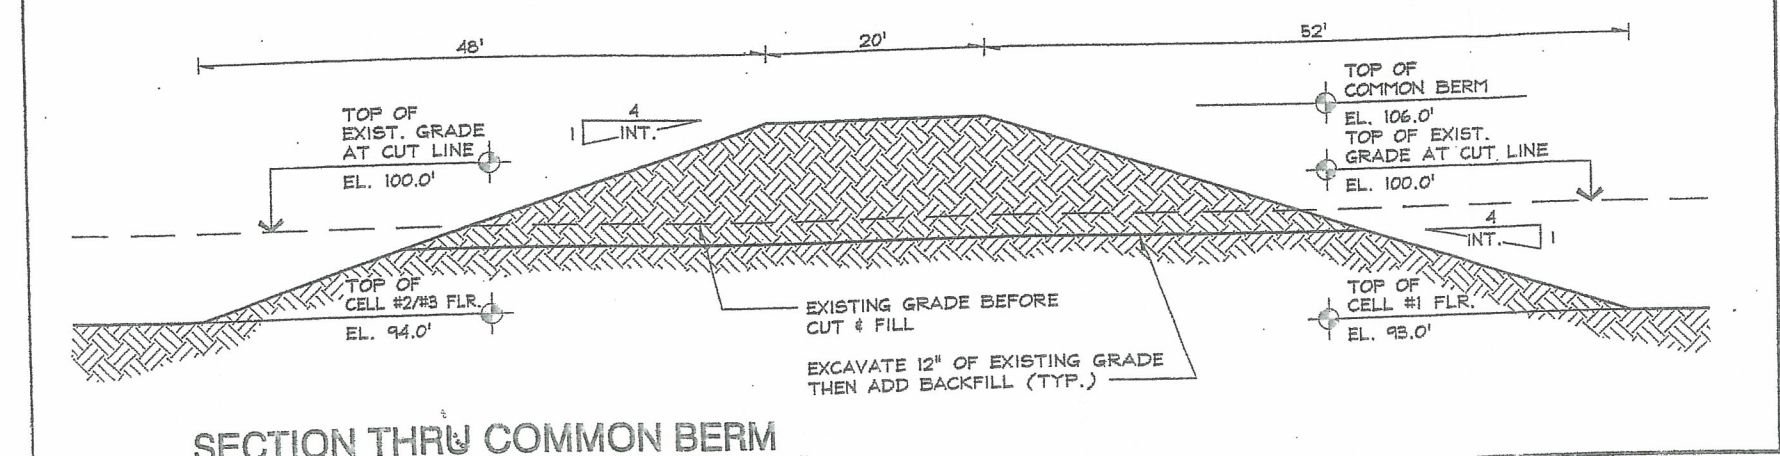

SECTION THRU COMMON BERM

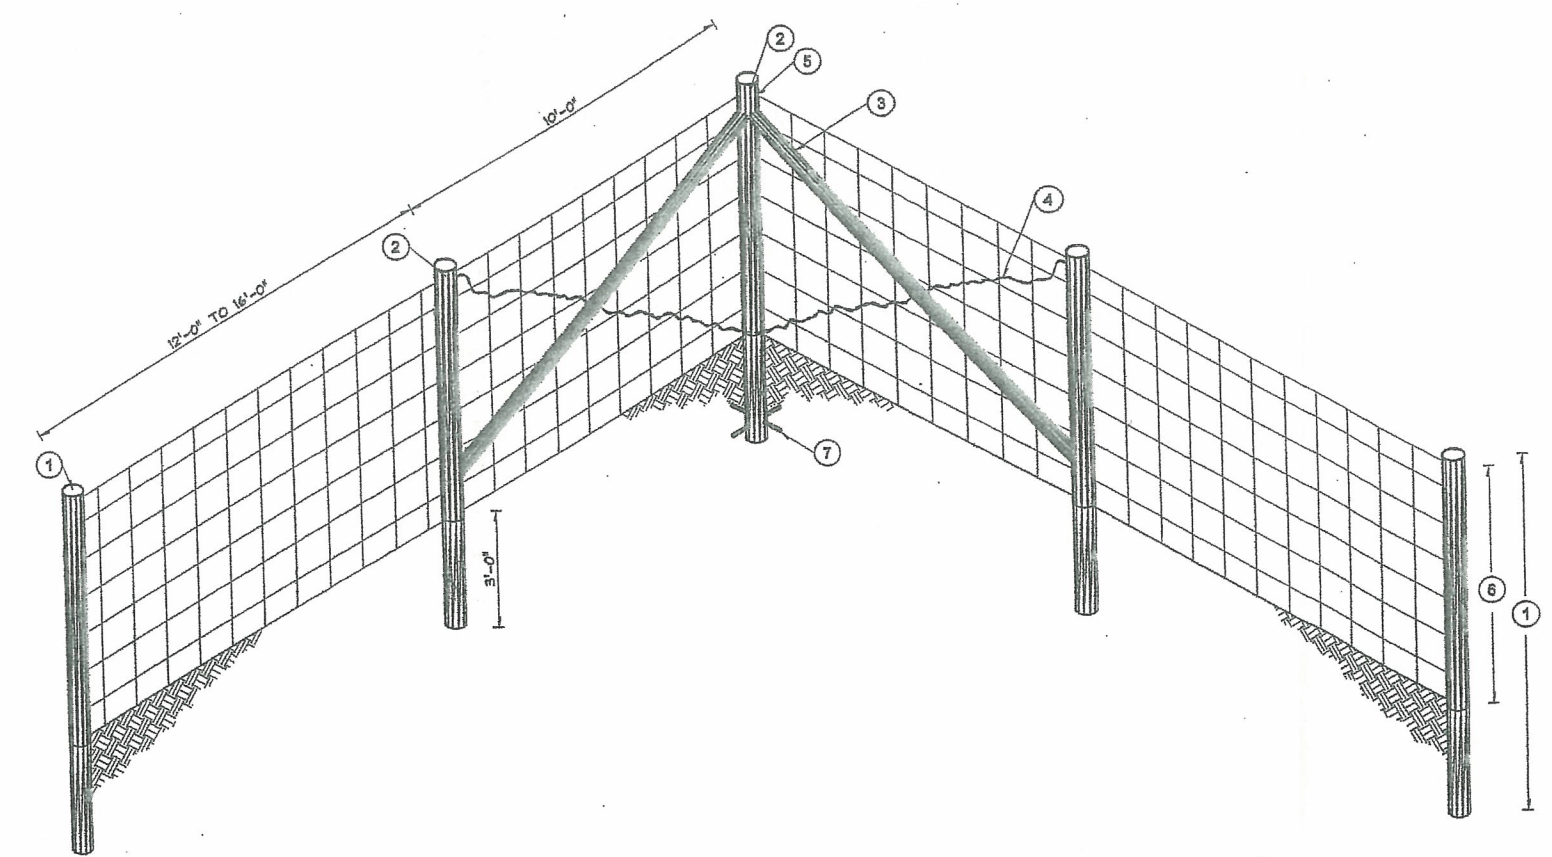

PAGE WIRE FENCE - ELEVATION VIEW


PAGE WIRE FENCING SPECIFICATIONS:

- FOR EXTRA SECURITY, BARBED WIRE CAN BE ADDED TO THE TOP OF THE FENCE. THIS MAY BE EITHER DOUBLE-STRAND TYPE OR SINGLE STRAND TYPE (HAS MORE BARBS).
- ANCHOR CORNER AND STRETCH POSTS MUST BE WOOD, BUT LINE POSTS MAY BE WOOD OR STEEL. PRESSURE TREATED WOOD POSTS ACCORDING TO CSA STANDARD 080 ARE RECOMMENDED.
- WHEN SECURING FENCING POSTS DO NOT TIGHTEN THE FENCE STAPLES OR WIRE TIES, OTHERWISE IT MAY BECOME IMPOSSIBLE TO GET A UNIFORM TENSION ON THE WIRES WHEN STRETCHING THE FENCE.

LEGEND

1	USE 5 INCH TOP DIAMETER PRESSURE TREATED WOOD POSTS OR COMMERCIAL STEEL POSTS TOTAL 7 FT POST LENGTH.
2	CORNER AND BRACE POSTS TO BE 6 INCH TOP DIAMETER
3	4 INCH DIAMETER BRACE RAIL TO BE NOTCHED AND SPIKED INTO 2 (TWO)
4	NO.9 (4mm) BRACE WIRE, TO TIGHTEN TWIST AT TWO LOCATIONS
5	START FENCING AT CORNER POSTS
6	PAGE WIRE FENCING 48 INCHES HIGH
7	CORNER AND END POST ANCHORS TO BE WIRED AND SPIKED TO POST

ISSUED FOR CONSTRUCTION

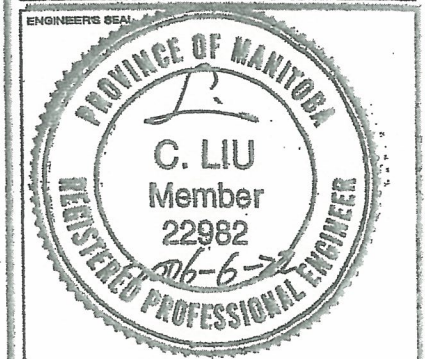

REVISION	NO.	DATE	DESCRIPTION	INITIAL
02	06/06/22	ISSUED FOR CONSTRUCTION	SM	
01	06/03/06	ISSUED FOR CONSTRUCTION	JJM	

COPYRIGHT (2006)
 COPYRIGHT RESERVED. THIS DRAWING AND DESIGN IS AND AT ALL TIMES REMAINS THE EXCLUSIVE PROPERTY OF DGH ENGINEERING LTD AND SHALL NOT BE USED WITHOUT THE ENGINEER'S CONSENT IN WRITING.
 THE CONTRACTOR SHALL CHECK AND VERIFY ALL DIMENSIONS AND REPORT ALL ERRORS AND OMISSIONS TO THE ENGINEER IN WRITING. DO NOT SCALE THIS DRAWING. THIS DRAWING SHALL NOT BE USED FOR CONSTRUCTION OR BUILDING PERMIT PURPOSES UNTIL SEALED AND SIGNED.



CLIENT
MIAMI COLONY
 BOX 131
 MORDEN, MANITOBA
 R6M 1V9

PROJECT TITLE
EARTHEN MANURE STORAGE BASIN RM OF THOMPSON
 LEGAL DESCRIPTION
NE 4-4-6 W
 PROJECT NUMBER: 06-1-1400-006-10 DATE: JUNE 2006

SECTIONS, & FENCE
 L2 CREV. F00