



NO.	BY:	DATE:	DESCRIPTION
REVISIONS			
ENVIRONMENTAL CONTROLS AND SERVICES MPLS., MN. 763-572-8042			
PROJECT #:	FOR:	DUPPS CO. / OLYMEL	
PA06-2235	TITLE:	PROCESS FLOW DIAGRAM FOR 12,000 CFM TWO-STAGE SCRUBBERS & 85,000 CFM PACKED BED SCRUBBERS	
DRAWN BY:	L. ANDERSON	DRAWING #:	A-FLW-3
DATE:	7/24/06	SHEET:	1 OF 1
SCALE:	N.T.S.	REV:	01


OLYWEST PLANT VIEW

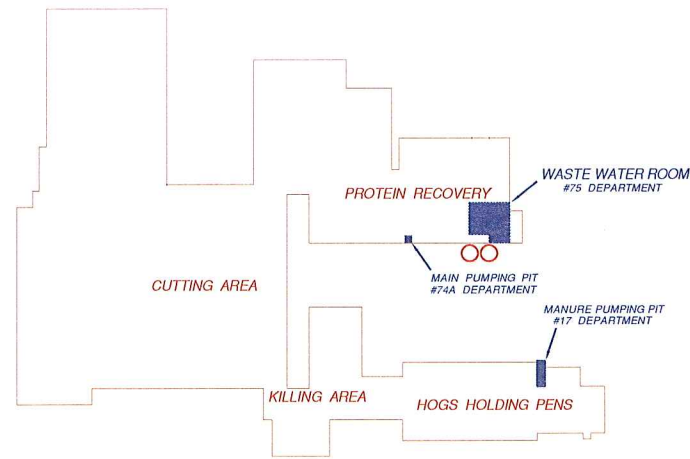

WASTE WATER ROOM LAYOUT

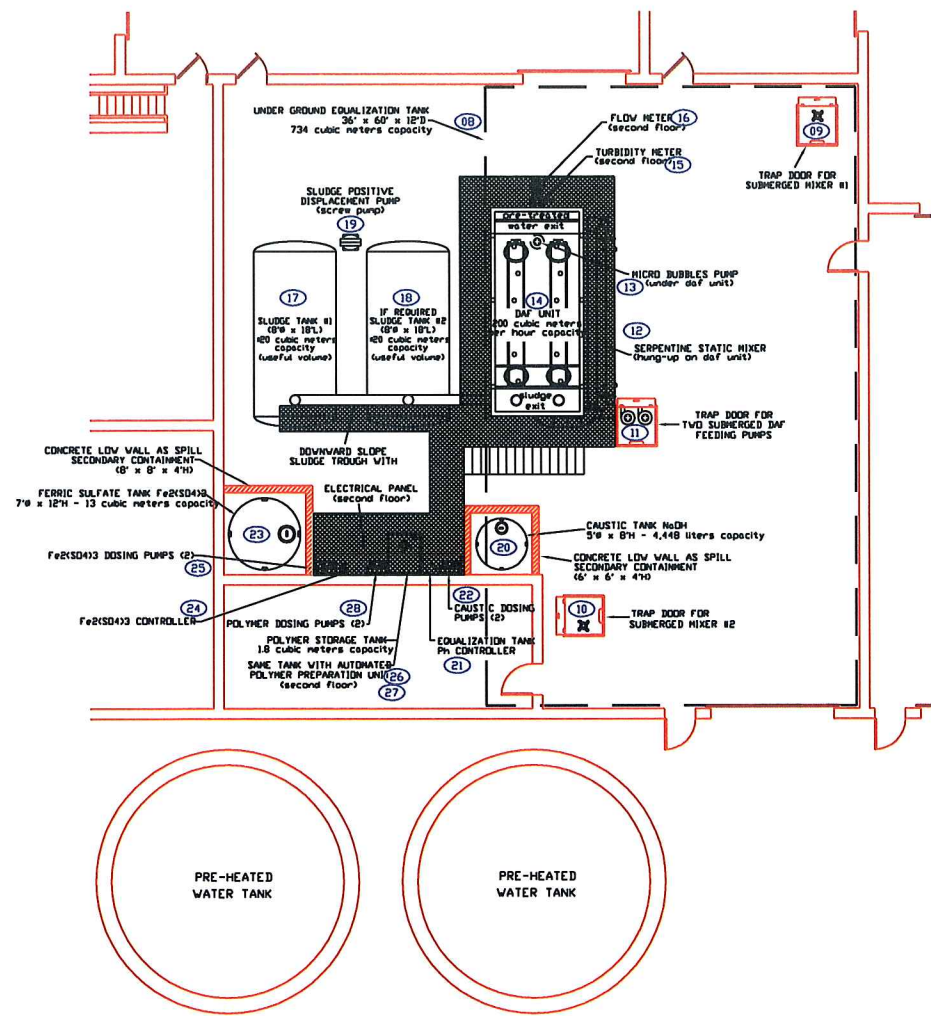

SCHEMATIC DIAGRAM

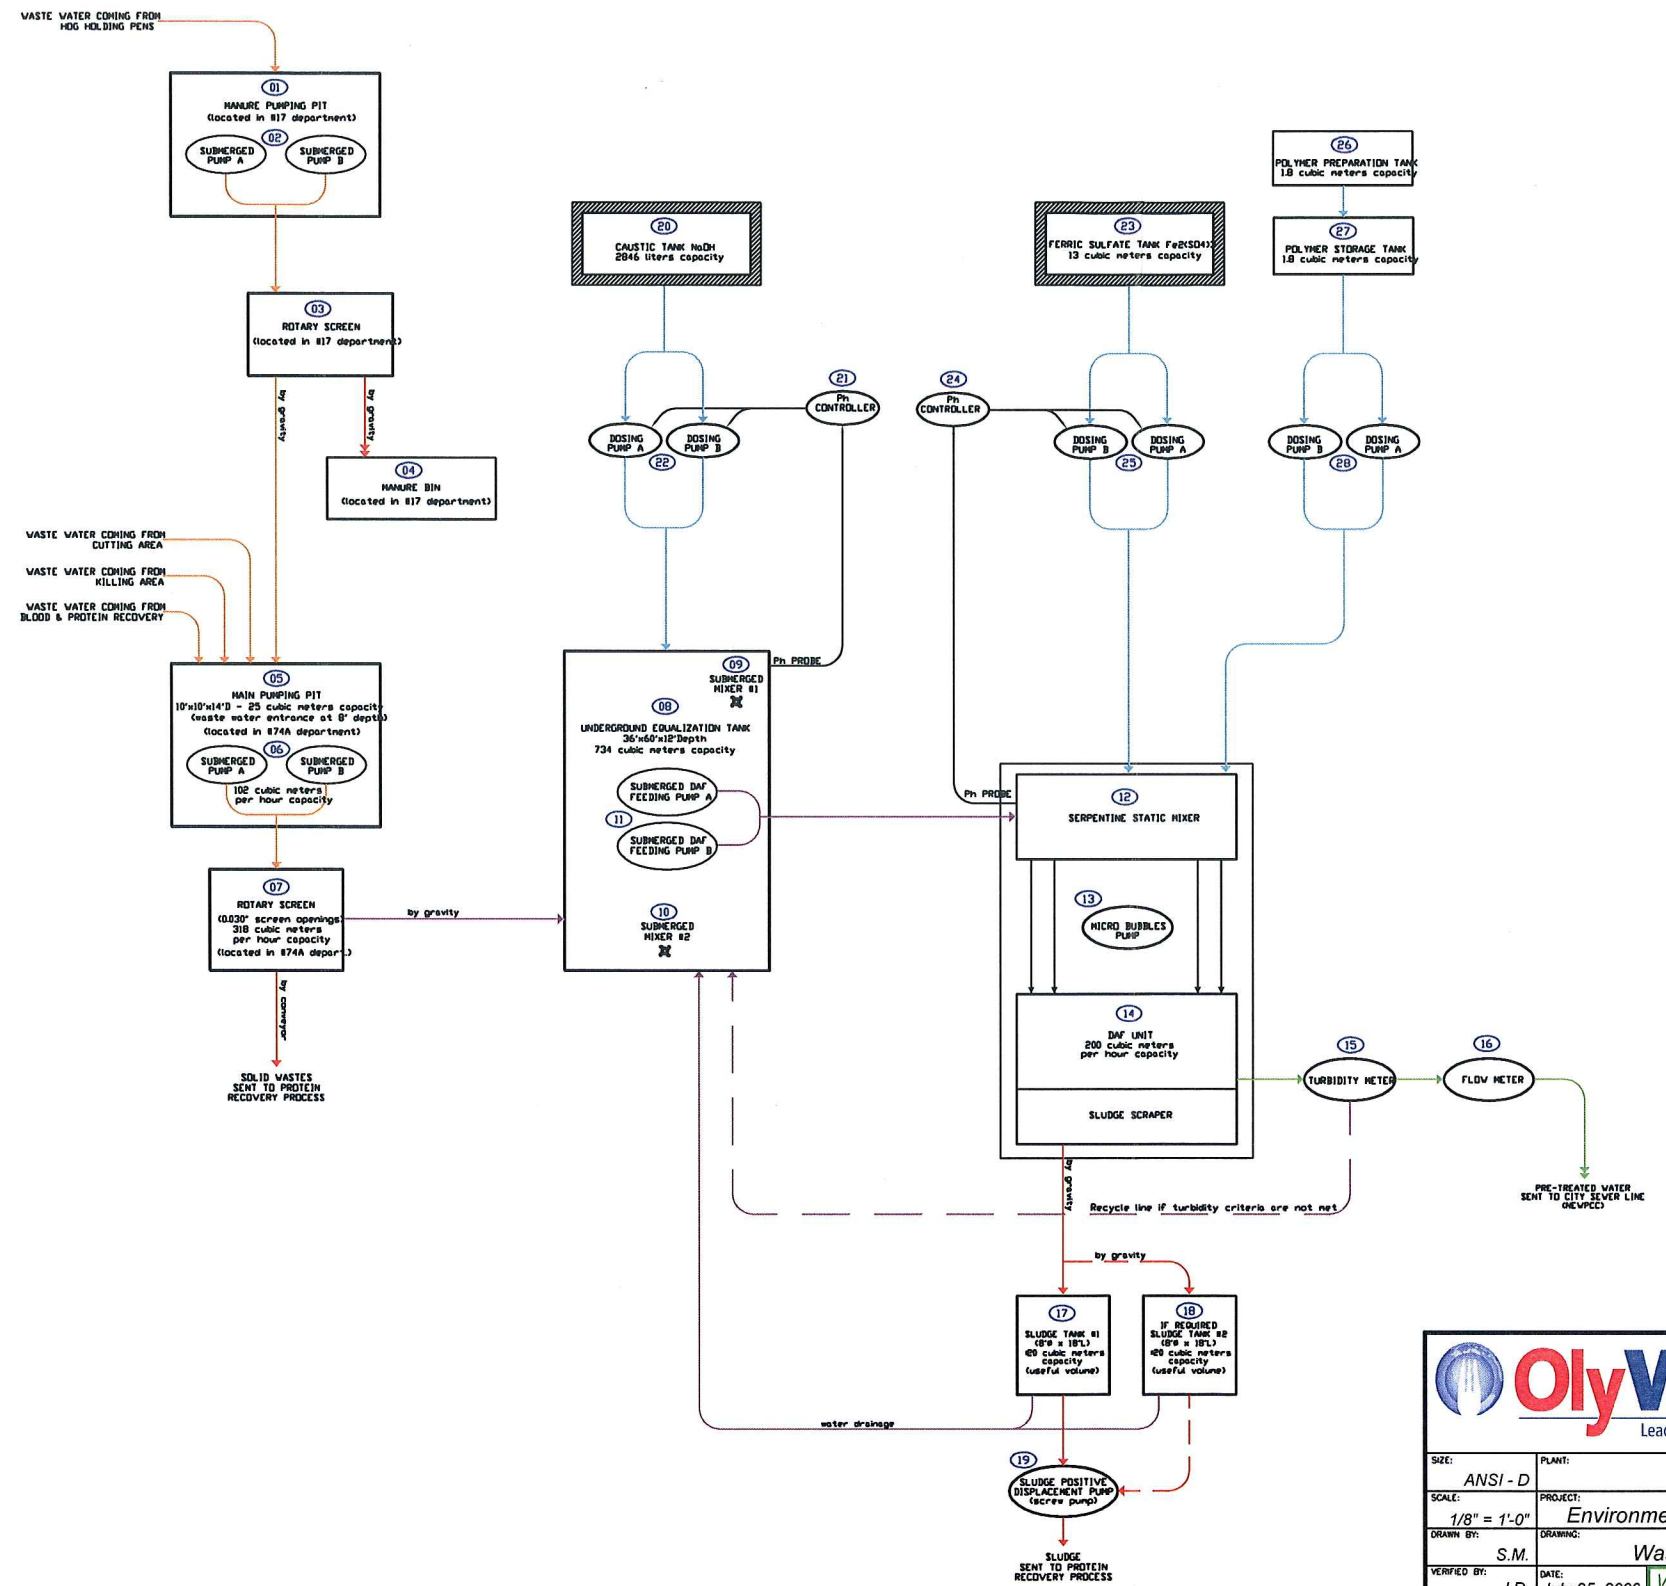

**OlyWest**  
Leadership with Vision

SIZE: ANSI - D	PLANT: Winnipeg
SCALE: 1/8" = 1'-0"	PROJECT: Environmental submission
DRAWN BY: S.M.	DRAWING: Waste water set-up
VERIFIED BY: J.D.	DATE: July 25, 2006 WES-060719-02



Earth Tech (Canada) Inc. Winnipeg, Manitoba 204.477.5381

OLYWEST ENVIRONMENTAL IMPACT ASSESSMENT WINNIPEG, MANITOBA



OlyWest Leadership with Vision

WASTEWATER PRE-TREATMENT

designed scale yy-mm-dd  
N.T.S. 06-08-04

drawn project no.  
LB 91511

checked drawing no. rev.  
SJB FIGURE 4.5  
approved